


PLAN

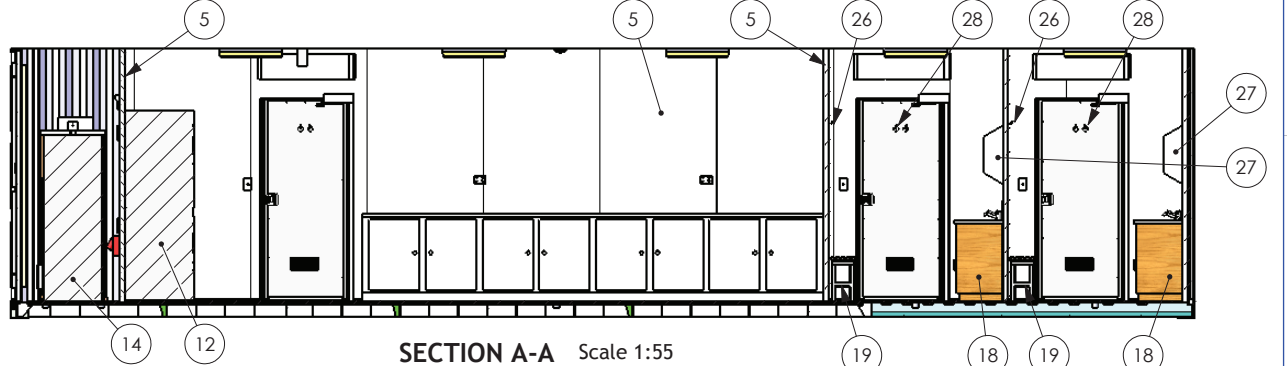

SECTION A-A Scale 1:55



ITEM NO.	QTY.	DESCRIPTION	NOTES
40	3	smoke detector	
39	1	HWS Brace	
38	9	isolator	
37	1	Steel Cabinet Model FSSH11 - 914 x 457 x 1800	
36	1	Penetration Box 200x200x90x3 with two 5/8 3/4" sockets	see details
35	5	Penetration Box 200x200x90x3	
34	2	Penetration Box 400x400x90x3	
33	3	Penetration for external lamp, Drg.No.RWT-CSC-HS276	
32	1	AC Aluminium Cover Plate, tread-face, 3x225(length to suit)	
31	2	Unistrut Supports - P1000 (41x41)	length to suit
30	2	Wall Mirror	
29	2	Toilet Paper Holder	
28	2	Soap Dispenser	
27	2	Paper Towell Dispenser - Roll	
26	10	Coat Hook	
25	2	Laundry Tub - 680 x 600 x 900	
24	6	Type 2 Vermin Proof Floor Drain	
23	2	Toilet & Cistern - P Trap	
22	2	Shower Curtain 2010	
21	2	Shower Rail 2010	
20	2	Shower, Single Mould 900x900	
19	2	Type 2 Shower Bench	
18	2	Type 2 Vanity	
17	1	Bench with cabinets, 4750 long 900hx600d	
16	1	Type 2 Cabinet Bund, for one steel cabinet	
15	1	HWS Tray 2010, 3 Points Vermin Proof Drainage	
14	2	315 Litre HWS Rapid Recovery 3 x 3.6KW - RHEEM 613316	
13	4	Washer LWS42	
12	2	Stack Dryer SSE807	
11	2	Exhaust Fan Ø100 as per Drg. RWT-CSC-HS254-002	on 10A supply
10	4	Vent, passive, Use McNaughtans PN MCN-LV-200x200, 2x13 Slots	
9	2	Alu Vent 400x1500	
8	2	Steel Strap for AC Outdoor Unit	
7	1	Mitsubishi AC Split System - Indoor - SRK35ZJ-S	
6	1	Mitsubishi AC Split System - Outdoor - SRK35ZJ-S	3.5 kW
5	AR	Ablution Laundry Lining	
4	AR	Floor Vinyl	
3	3	DOOR CLOSER, automatic heavy duty	
2	3	PA Door, per Drg. RWT-CSC-HS266-001 with Door Vent 150x300	
1	1	Ablution Laundry CONTAINER	

- NOTES:
- ALL PLUMBING TO BE COPPER TUBED. PLUMBING INSTALLATION IN ACCORDANCE WITH AS/NZS 3500-2003 .
 - ELECTRICAL INSTALLATION IN ACCORDANCE WITH AS/NZS 3000-2007 & AS/NZS 3001-2008.
 - FOR ELECTRICAL LAYOUT DRG. SEE RWT-NMD-HS626-003 .
 - COMMERCIAL VINYL FLOORING COVERED 100mm.
 - PADS TO BE REBATE STYLE WEATHER PROOF WITH HEAVY DUTY DOOR CLOSERS AND PASSIVE AIR VENTS.
 - A/C HEAD TO BE SECURED, TOP AND BOTTOM WITH ANGLES.
 - CONTAINER TO BE PAINTED WHITE EXTERNALLY WITH 304 SPRAYING ENAMEL.
 - IF IN DOUBT ASK.


REVISIONS				
REV.	DESCRIPTION	DATE	DRAWN BY	APPROVED
2	DRG. created from RWT-NMD-HS626-00, vent SIZE CHANGED TO SUIT LOCKING BARS	27/09/2012	MKB	
3	AS BUILT REVISION	17/05/2013	MKB	

APPROVED FOR PRODUCTION

<p>Royal Wolf Trading ABN 38 069 244 417 4/50 RAUBERS ROAD NORTHGATE QLD 4013 P.O. Box 161 BANYO, QLD, 4013 Ph +61 7 3267 3655 Fx +61 7 3267 3699</p>	<p>PAPER: A3 SCALE: STATED MASS: KG DESIGNED: JIM J DRAWN: JIM J 02/04/2012 CHECKED: RWT APP: CLIENT APP:</p>	<p>CLIENT: RWT PROJECT: PA# 12-0054 AREA: NATIONAL MINING & DEFENCE DRAWING TITLE: 40' ABLUTIONS LAUNDRY FURTHER DESCRIPTION: GENERAL ASSEMBLY</p>	<p>THIS DRAWING IS THE PROPERTY OF ROYAL WOLF TRADING PTY LTD AND IS CONDITIONALLY LOANED TO THE RECIPIENT WHO BY RECEIVING IT HAS AGREED NOT TO REPRODUCE IT IN WHOLE OR IN PART. NOR MAKE ANY USE OF IT THAT HAS NOT BEEN APPROVED IN WRITING BY ROYAL WOLF TRADING PTY LTD</p>	
	<p>GENERAL FABRICATION TOLERANCES 0-50 mm: ±0.5 mm 51mm-1M: ±1.0 mm 1.001M - 6.1 M: ±2.0 mm 6.101 M - 13 M: ±3.0 mm</p>	<p>SHEET: SHEET 1 OF 6 REVISION: 3 REVISION DATE:</p>	<p>DRAWING NUMBER: RWT-NMD-HS777-001</p>	

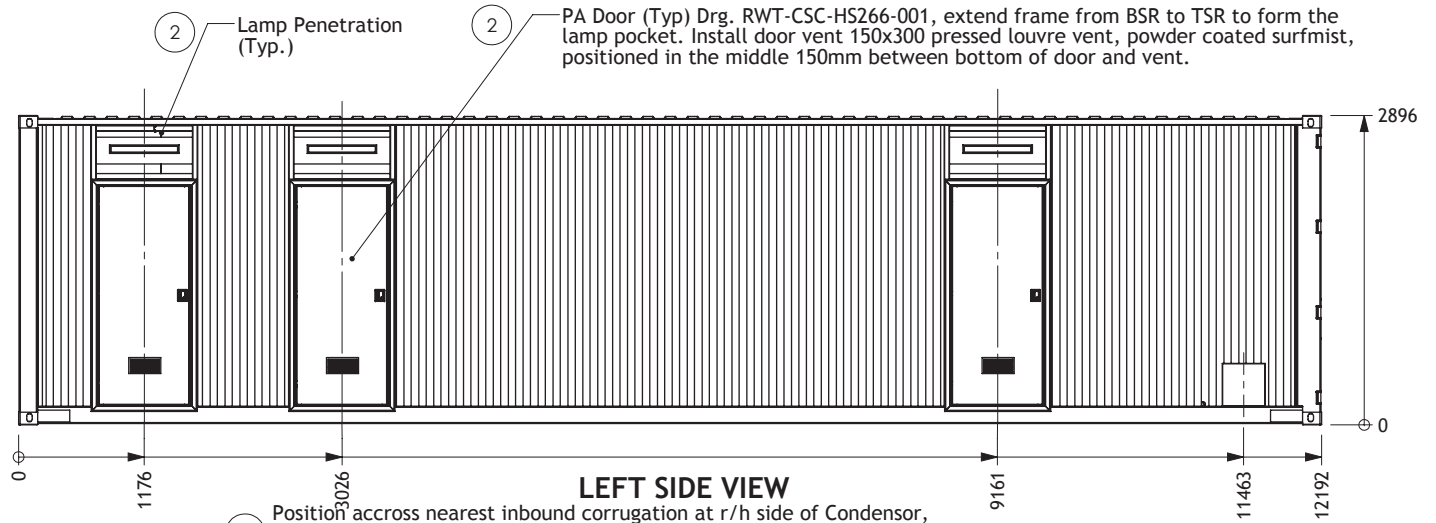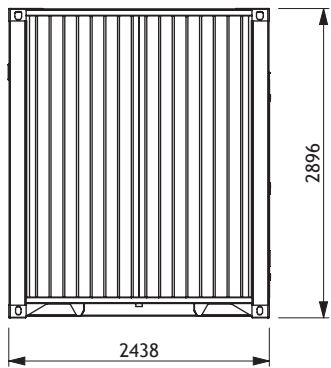


LEFT SIDE VIEW

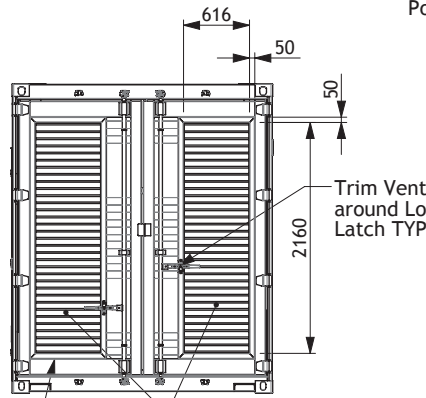


RHS frames for vents 100x50x2.5, inside size 716x2160

Power-In 50Amp, 3-Phase

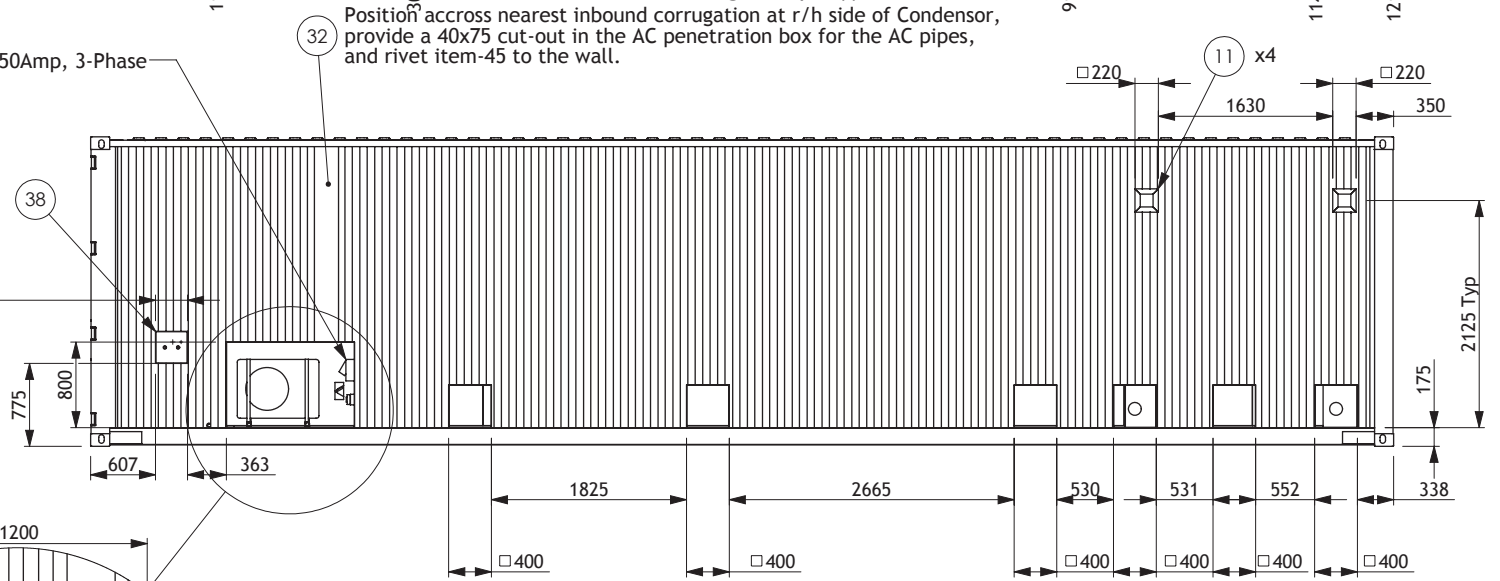

RIGHT SIDE VIEW

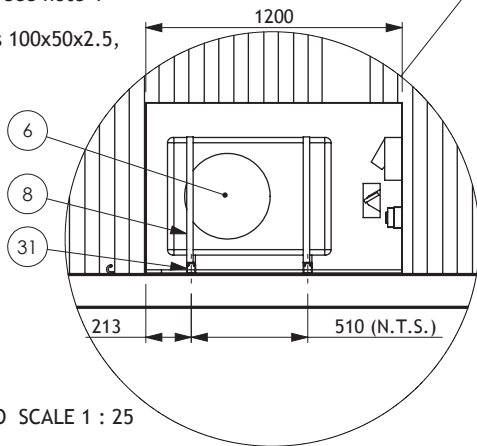

DETAIL O SCALE 1 : 25



Royal Wolf Trading
 ABN 38 069 244 417
 4/50 RALIBERS ROAD
 NORTHGATE
 QLD 4013
 P.O. Box 161
 BANYO, QLD, 4013
 Ph +61 7 3267 3655
 Fx +61 7 3267 3699



PAPER	A3
SCALE	STATED
MASS	KG
DESIGNED	
DRAWN	MKB 04/05/2012
CHECKED	
RWT APP.	
CLIENT APP.	
GENERAL FABRICATION TOLERANCES	
0-50 mm:	±0.5 mm
51mm-1M:	±1.0 mm
1.001M - 6.1 M:	±2.0 mm
6.101 M - 13 M:	±3.0 mm

CLIENT	RWT
PROJECT	PA# 12-0054
AREA	NATIONAL MINING & DEFENCE
DRAWING TITLE	40' ABLUTIONS LAUNDRY
FURTHER DESCRIPTION	GENERAL ASSEMBLY

APPROVED FOR PRODUCTION

THIS DRAWING IS THE PROPERTY OF ROYAL WOLF TRADING PTY LTD AND IS CONDITIONALLY LOANED TO THE RECIPIENT WHO BY RECEIVING IT HAS AGREED NOT TO REPRODUCE IT IN WHOLE OR IN PART. NOR MAKE ANY USE OF IT THAT HAS NOT BEEN APPROVED IN WRITING BY ROYAL WOLF TRADING PTY LTD

SHEET	REVISION	REVISION DATE
SHEET 2 OF 6	3	
DRAWING NUMBER		
RWT-NMD-HS777-001		

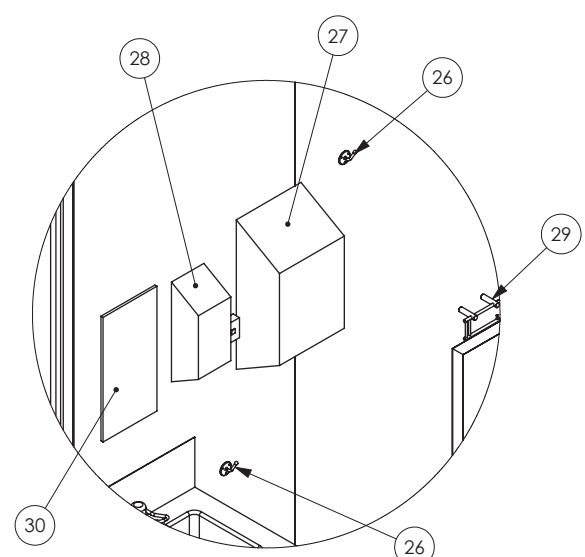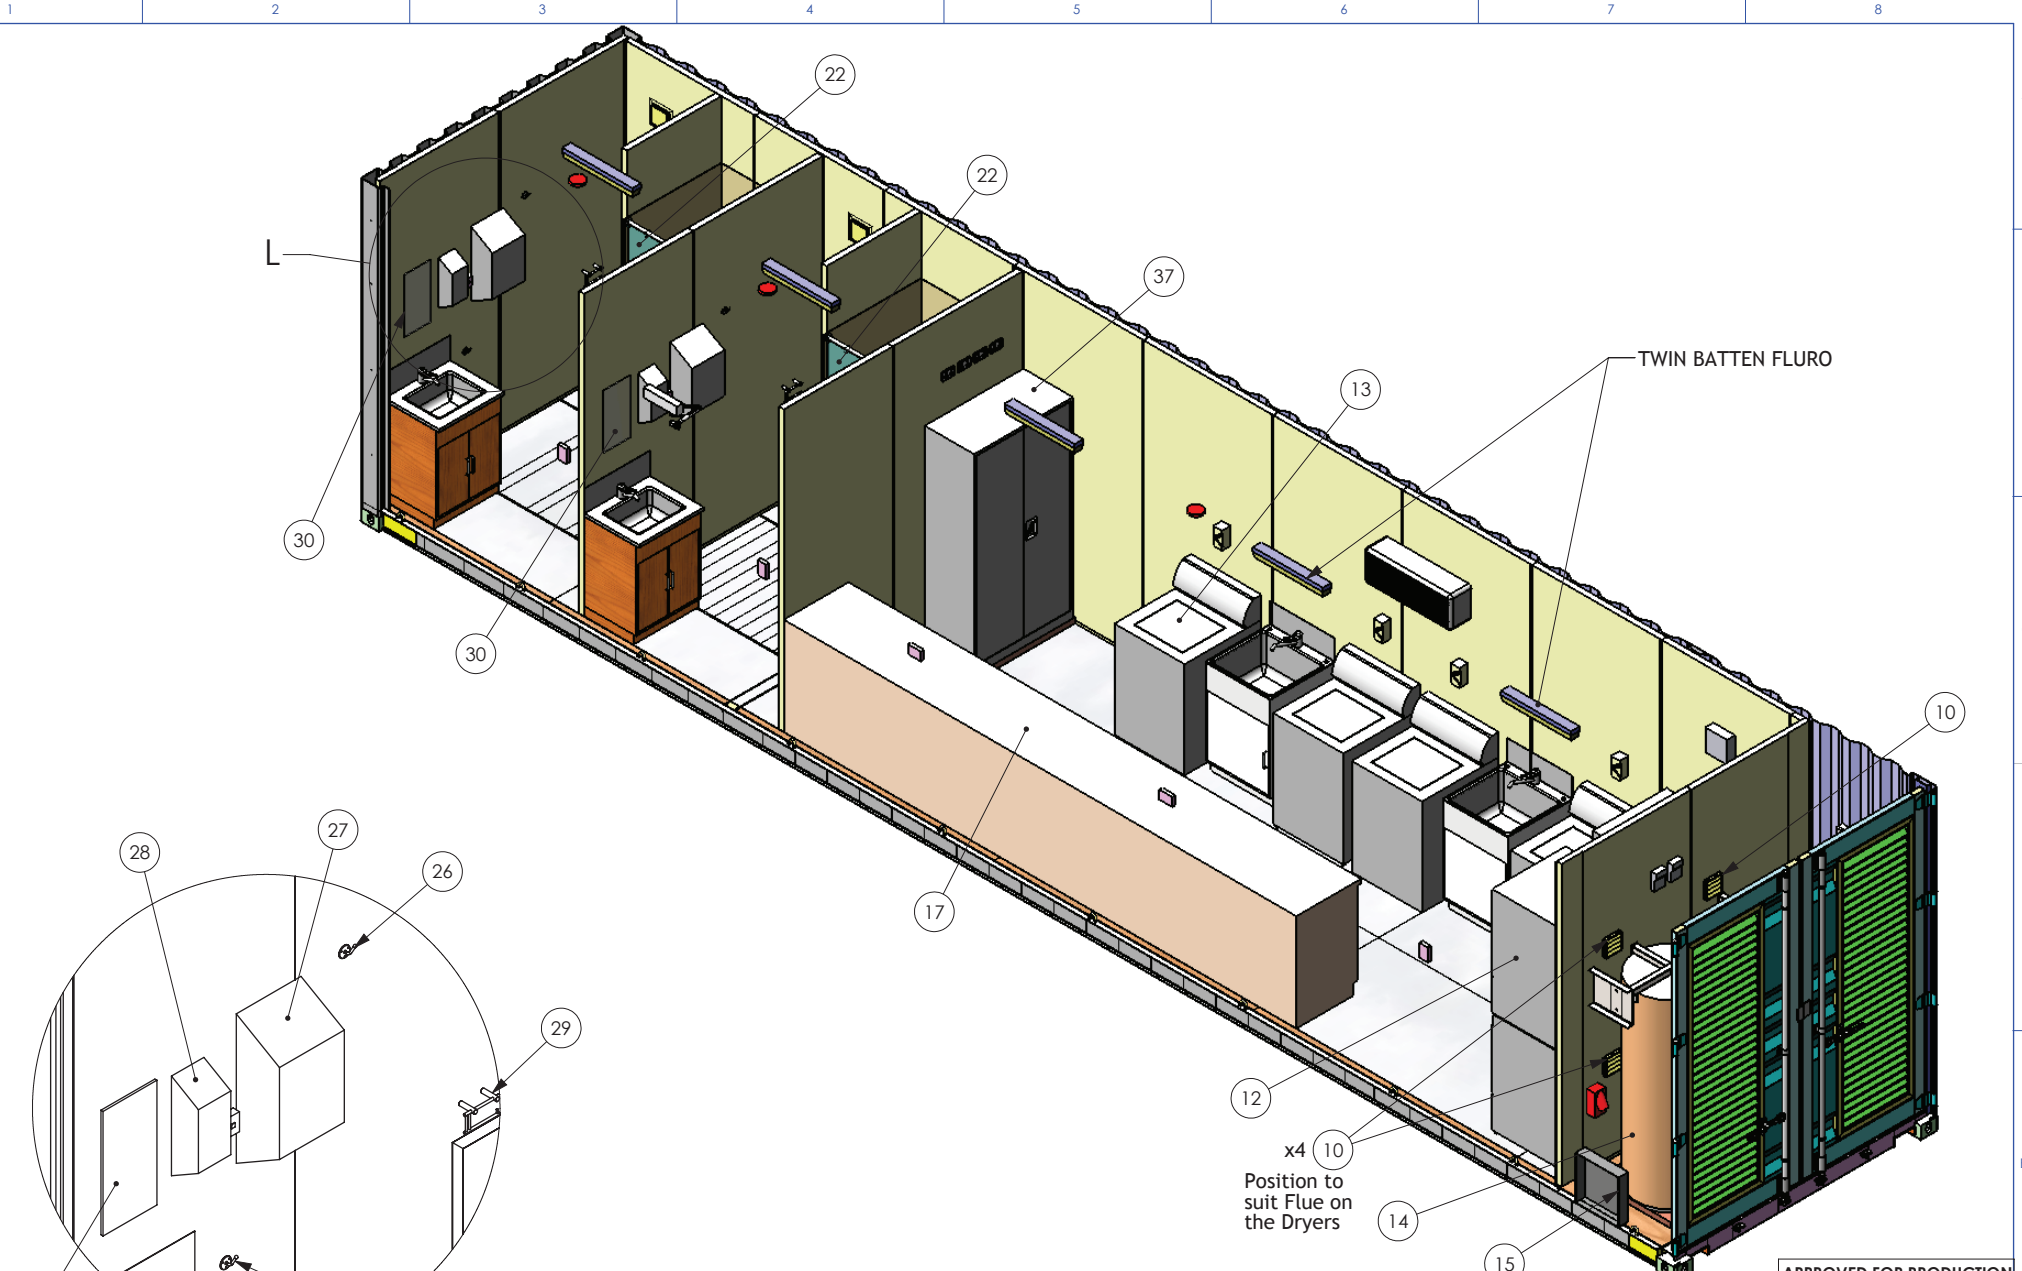

DETAIL L SCALE 2 : 35

APPROVED FOR PRODUCTION




Royal Wolf Trading
 ABN 38 069 244 417
 4/50 RAUBERS ROAD
 NORTHGATE
 QLD 4013
 P.O. Box 161
 BANYO, QLD, 4013
 Ph +61 7 3267 3655
 Fx +61 7 3267 3699

PAPER	A3
SCALE	STATED
MASS	KG
DESIGNED	
DRAWN	MKB 04/05/2012
CHECKED	
RWT APP.	
CLIENT APP.	
GENERAL FABRICATION TOLERANCES	
0-50 mm:	±0.5 mm
51mm-1M:	±1.0 mm
1.001M - 6.1 M:	±2.0 mm
6.101 M - 13 M:	±3.0 mm

CLIENT	RWT
PROJECT	PA# 12-0054
AREA	NATIONAL MINING & DEFENCE
DRAWING TITLE	40' ABLUTIONS LAUNDRY
FURTHER DESCRIPTION	GENERAL ASSEMBLY

THIS DRAWING IS THE PROPERTY OF ROYAL WOLF TRADING PTY LTD AND IS CONDITIONALLY LOANED TO THE RECIPIENT WHO BY RECEIVING IT HAS AGREED NOT TO REPRODUCE IT IN WHOLE OR IN PART. NOR MAKE ANY USE OF IT THAT HAS NOT BEEN APPROVED IN WRITING BY ROYAL WOLF TRADING PTY LTD		
SHEET	REVISION	REVISION DATE
SHEET 3 OF 6	3	
DRAWING NUMBER		
RWT-NMD-HS777-001		

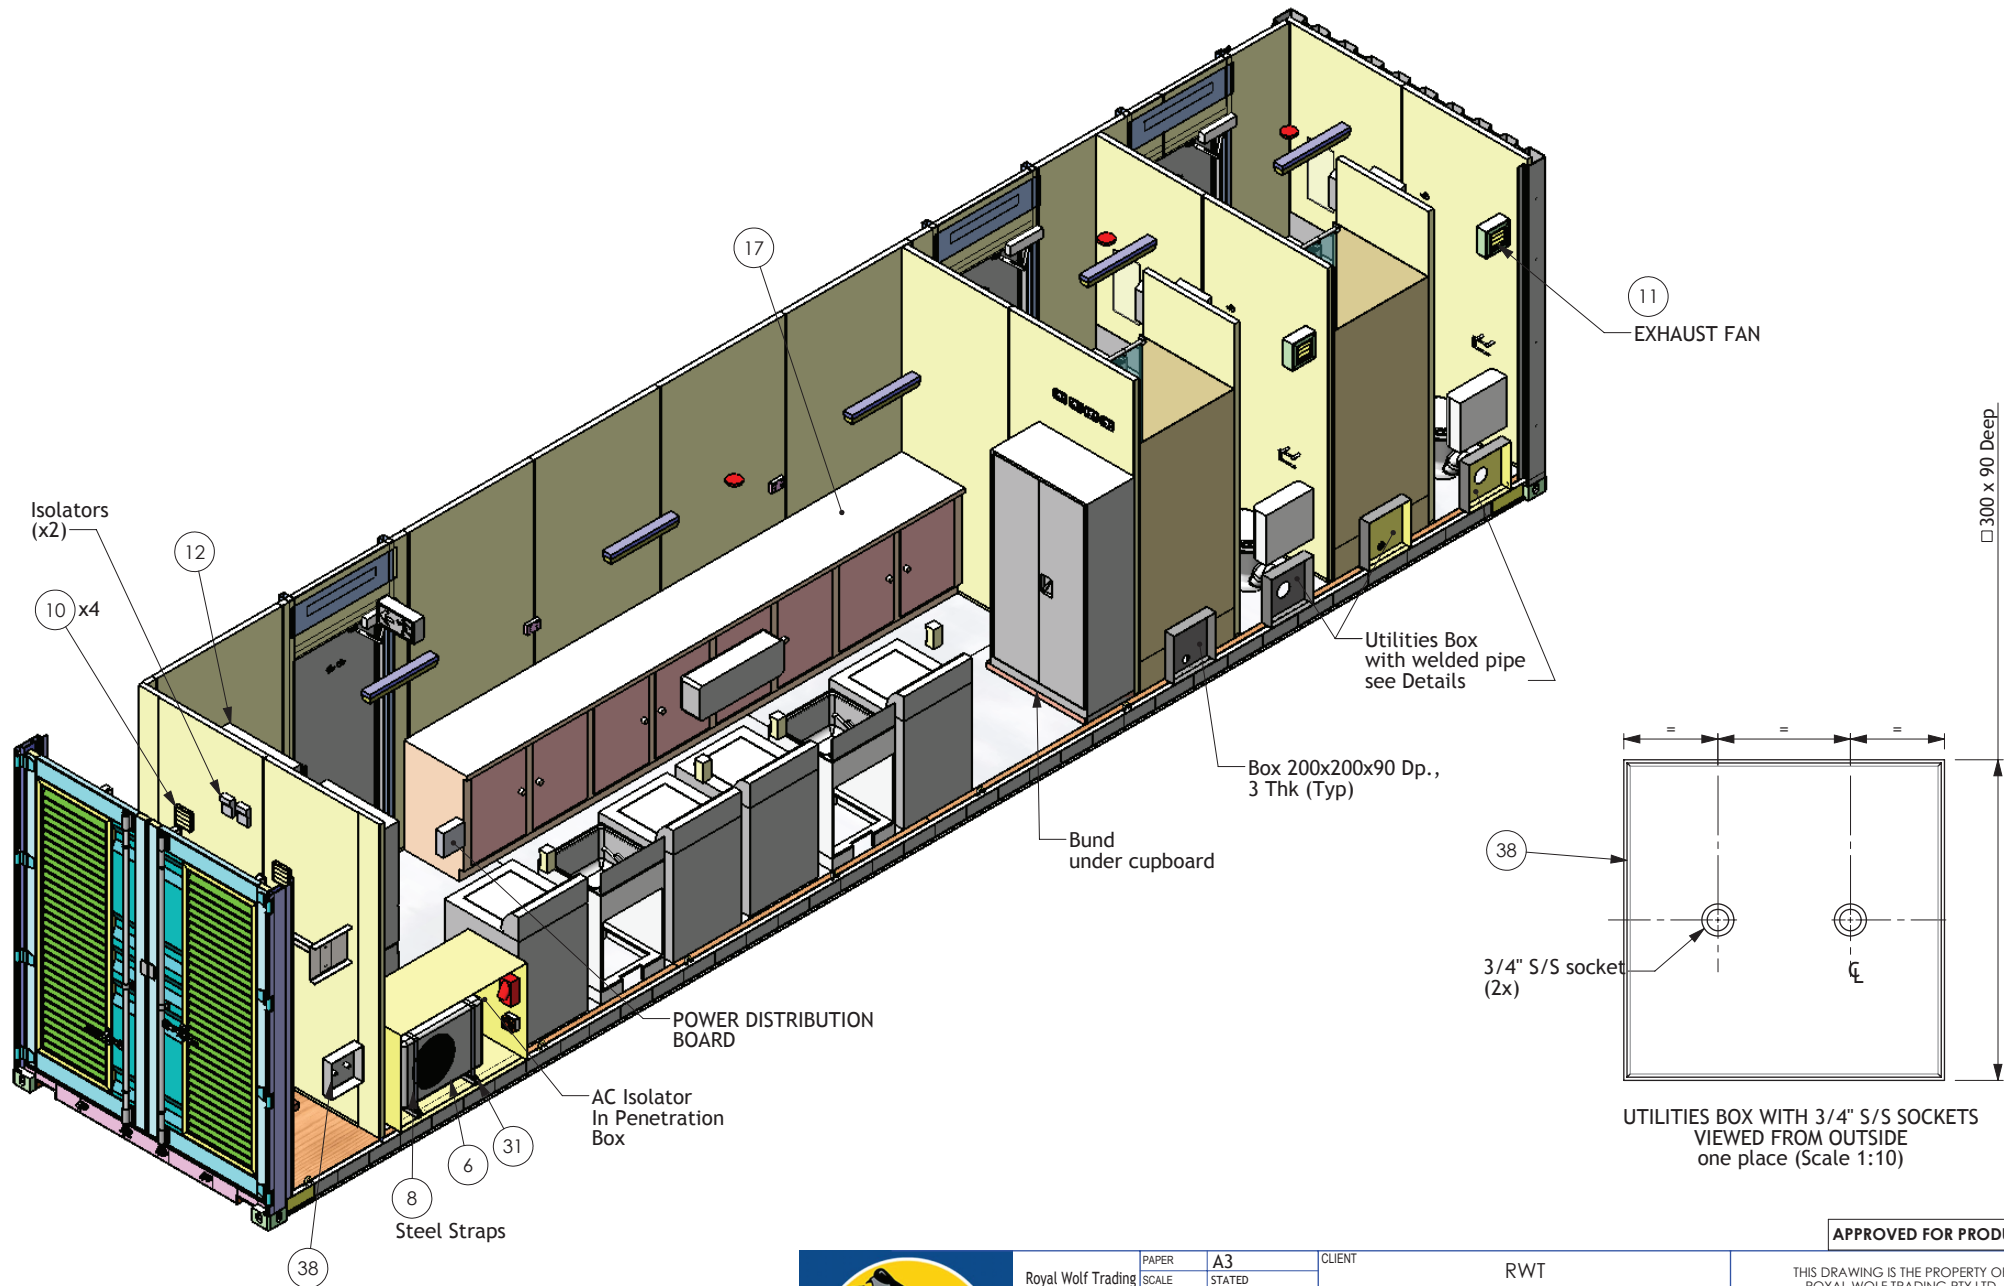


Royal Wolf Trading
 ABN 38 069 244 417
 4/50 RAUBERS ROAD
 NORTHGATE
 QLD 4013
 P.O. Box 161
 BANYO, QLD, 4013
 Ph +61 7 3267 3655
 Fx +61 7 3267 3699

PAPER	A3
SCALE	STATED
MASS	KG
DESIGNED	
DRAWN	MKB 04/05/2012
CHECKED	
RWT APP.	
CLIENT APP.	
GENERAL FABRICATION TOLERANCES	
0-50 mm:	±0.5 mm
51mm-1M:	±1.0 mm
1.001M - 6.1 M:	±2.0 mm
6.101 M - 13 M:	±3.0 mm

CLIENT	RWT
PROJECT	PA# 12-0054
AREA	NATIONAL MINING & DEFENCE
DRAWING TITLE	40' ABLUTIONS LAUNDRY
FURTHER DESCRIPTION	GENERAL ASSEMBLY

APPROVED FOR PRODUCTION		
THIS DRAWING IS THE PROPERTY OF ROYAL WOLF TRADING PTY LTD AND IS CONDITIONALLY LOANED TO THE RECIPIENT WHO BY RECEIVING IT HAS AGREED NOT TO REPRODUCE IT IN WHOLE OR IN PART, NOR MAKE ANY USE OF IT THAT HAS NOT BEEN APPROVED IN WRITING BY ROYAL WOLF TRADING PTY LTD		
SHEET	REVISION	REVISION DATE
SHEET 4 OF 6	3	
DRAWING NUMBER		
RWT-NMD-HS777-001		

Isolators for dryers,
typ. 4 places

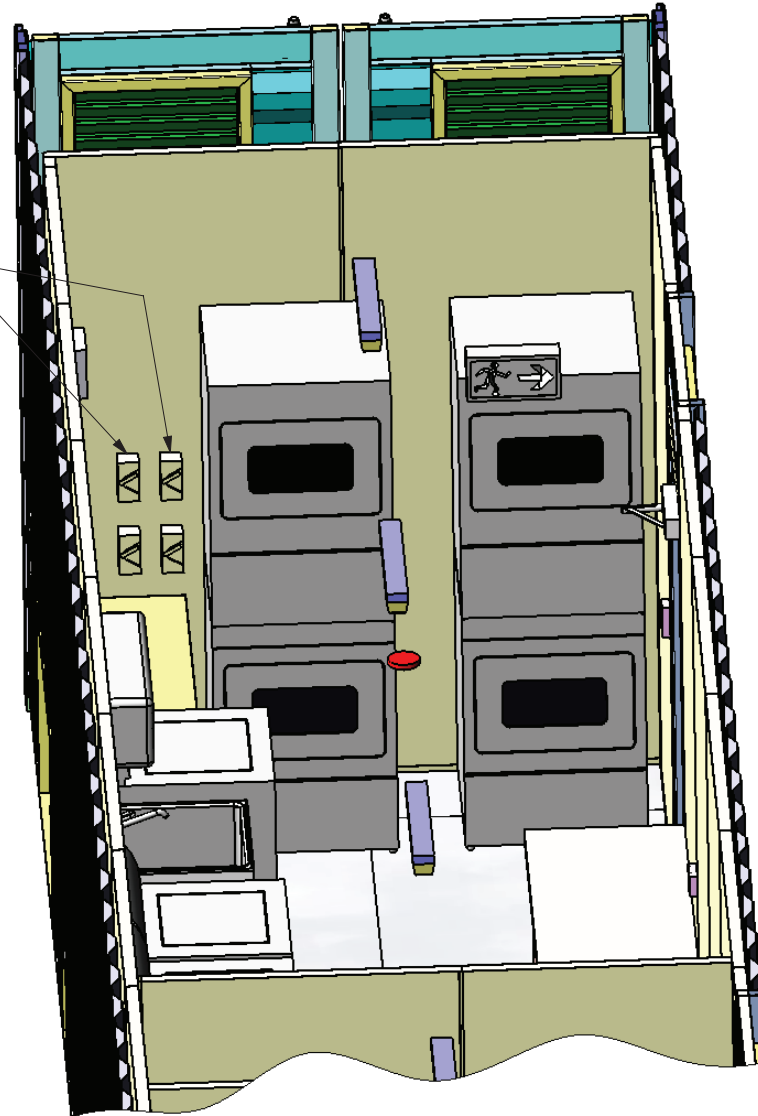

PARTIAL VIEW ONTO DRYERS



Royal Wolf Trading
ABN 38 069 244 417
4/50 RAUBERS ROAD
NORTHGATE
QLD 4013
P.O. Box 161
BANYO, QLD, 4013
Ph +61 7 3267 3655
Fx +61 7 3267 3699


PAPER	A3
SCALE	STATED
MASS	KG
DESIGNED	
DRAWN	MKB 04/05/2012
CHECKED	
RWT APP.	
CLIENT APP.	
GENERAL FABRICATION TOLERANCES	
0-50 mm:	±0.5 mm
51mm-1M:	±1.0 mm
1.001M - 6.1 M:	±2.0 mm
6.101 M - 13 M:	±3.0 mm

CLIENT	RWT
PROJECT	PA# 12-0054
AREA	NATIONAL MINING & DEFENCE
DRAWING TITLE	40' ABLUTIONS LAUNDRY
FURTHER DESCRIPTION	GENERAL ASSEMBLY


APPROVED FOR PRODUCTION

THIS DRAWING IS THE PROPERTY OF
ROYAL WOLF TRADING PTY LTD
AND IS CONDITIONALLY LOANED TO THE RECIPIENT
WHO BY RECEIVING IT HAS AGREED NOT TO
REPRODUCE IT IN WHOLE OR IN PART, NOR MAKE
ANY USE OF IT THAT HAS NOT BEEN APPROVED IN
WRITING BY ROYAL WOLF TRADING PTY LTD

SHEET	REVISION	REVISION DATE
SHEET 5 OF 6	3	
DRAWING NUMBER		
RWT-NMD-HS777-001		

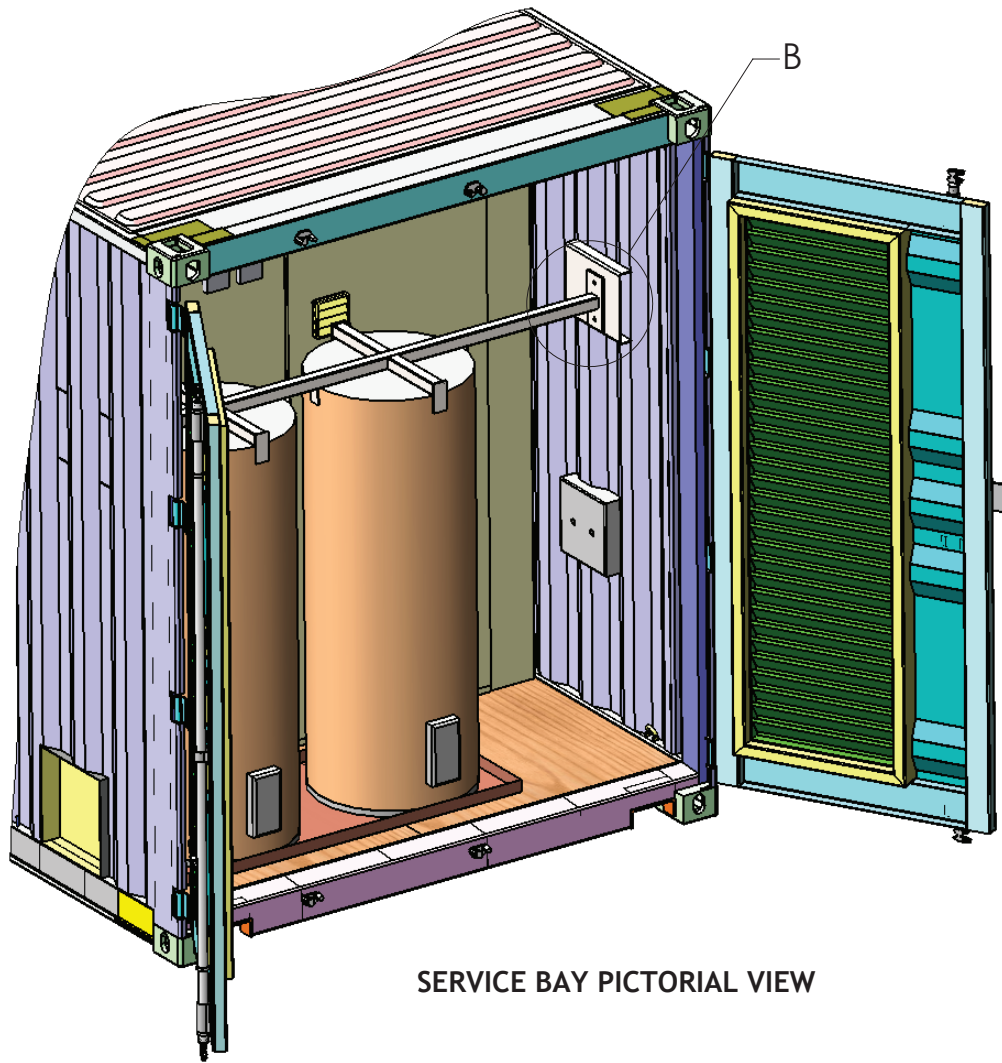


SERVICE BAY PICTORIAL VIEW

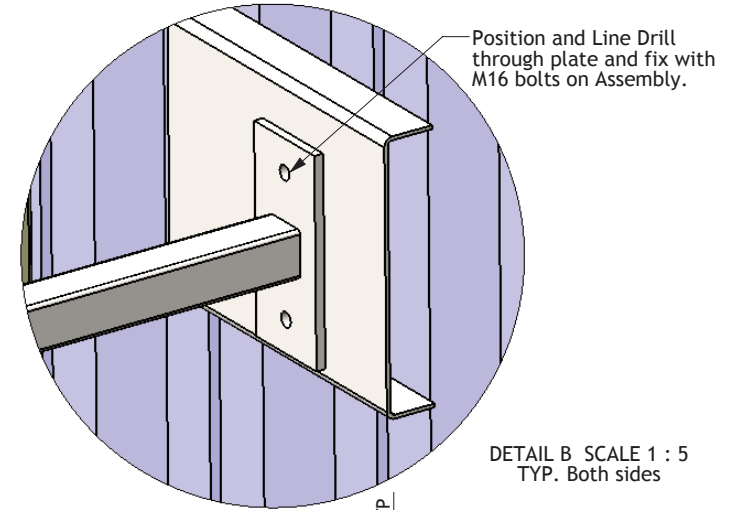

Position and Line Drill through plate and fix with M16 bolts on Assembly.

DETAIL B SCALE 1 : 5 TYP. Both sides

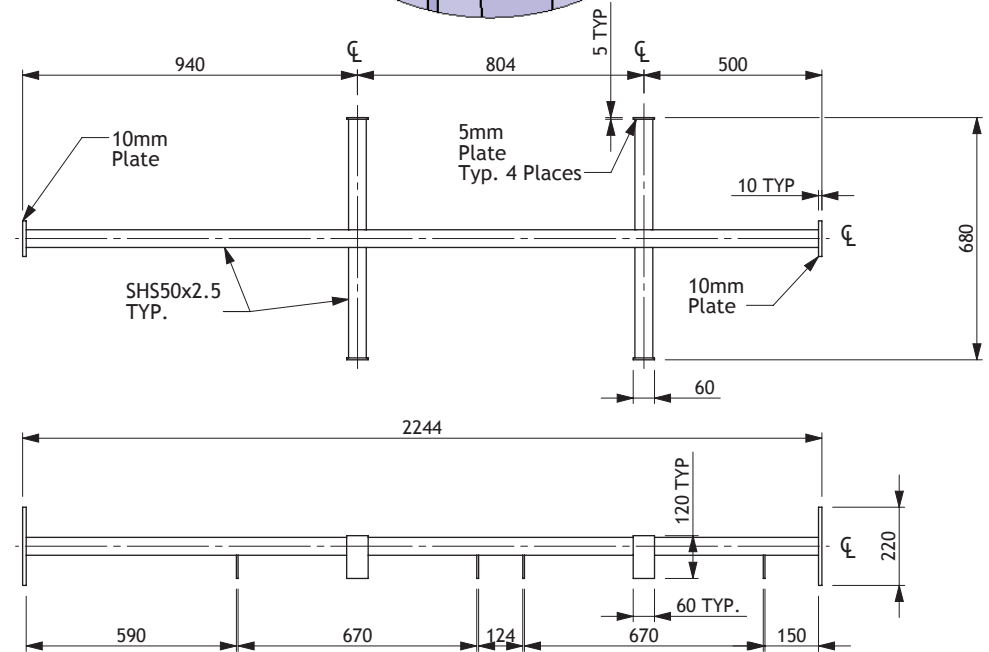

ITEM 41, HWS BRACE
STEEL CONSTRUCTION

APPROVED FOR PRODUCTION



Royal Wolf Trading
ABN 38 069 244 417
4/50 RAUBERS ROAD
NORTHGATE
QLD 4013
P.O. Box 161
BANYO, QLD, 4013
Ph +61 7 3267 3655
Fx +61 7 3267 3699

PAPER	A3
SCALE	STATED
MASS	KG
DESIGNED	
DRAWN	MKB 04/05/2012
CHECKED	
RWT APP.	
CLIENT APP.	
GENERAL FABRICATION TOLERANCES	
0-50 mm:	±0.5 mm
51mm-1M:	±1.0 mm
1.001M - 6.1 M:	±2.0 mm
6.101 M - 13 M:	±3.0 mm

CLIENT	RWT
PROJECT	PA# 12-0054
AREA	NATIONAL MINING & DEFENCE
DRAWING TITLE	40' ABLUTIONS LAUNDRY
FURTHER DESCRIPTION	GENERAL ASSEMBLY

THIS DRAWING IS THE PROPERTY OF ROYAL WOLF TRADING PTY LTD AND IS CONDITIONALLY LOANED TO THE RECIPIENT WHO BY RECEIVING IT HAS AGREED NOT TO REPRODUCE IT IN WHOLE OR IN PART, NOR MAKE ANY USE OF IT THAT HAS NOT BEEN APPROVED IN WRITING BY ROYAL WOLF TRADING PTY LTD		
SHEET	REVISION	REVISION DATE
SHEET 6 OF 6	3	
DRAWING NUMBER		
RWT-NMD-HS777-001		