


8
DP842243

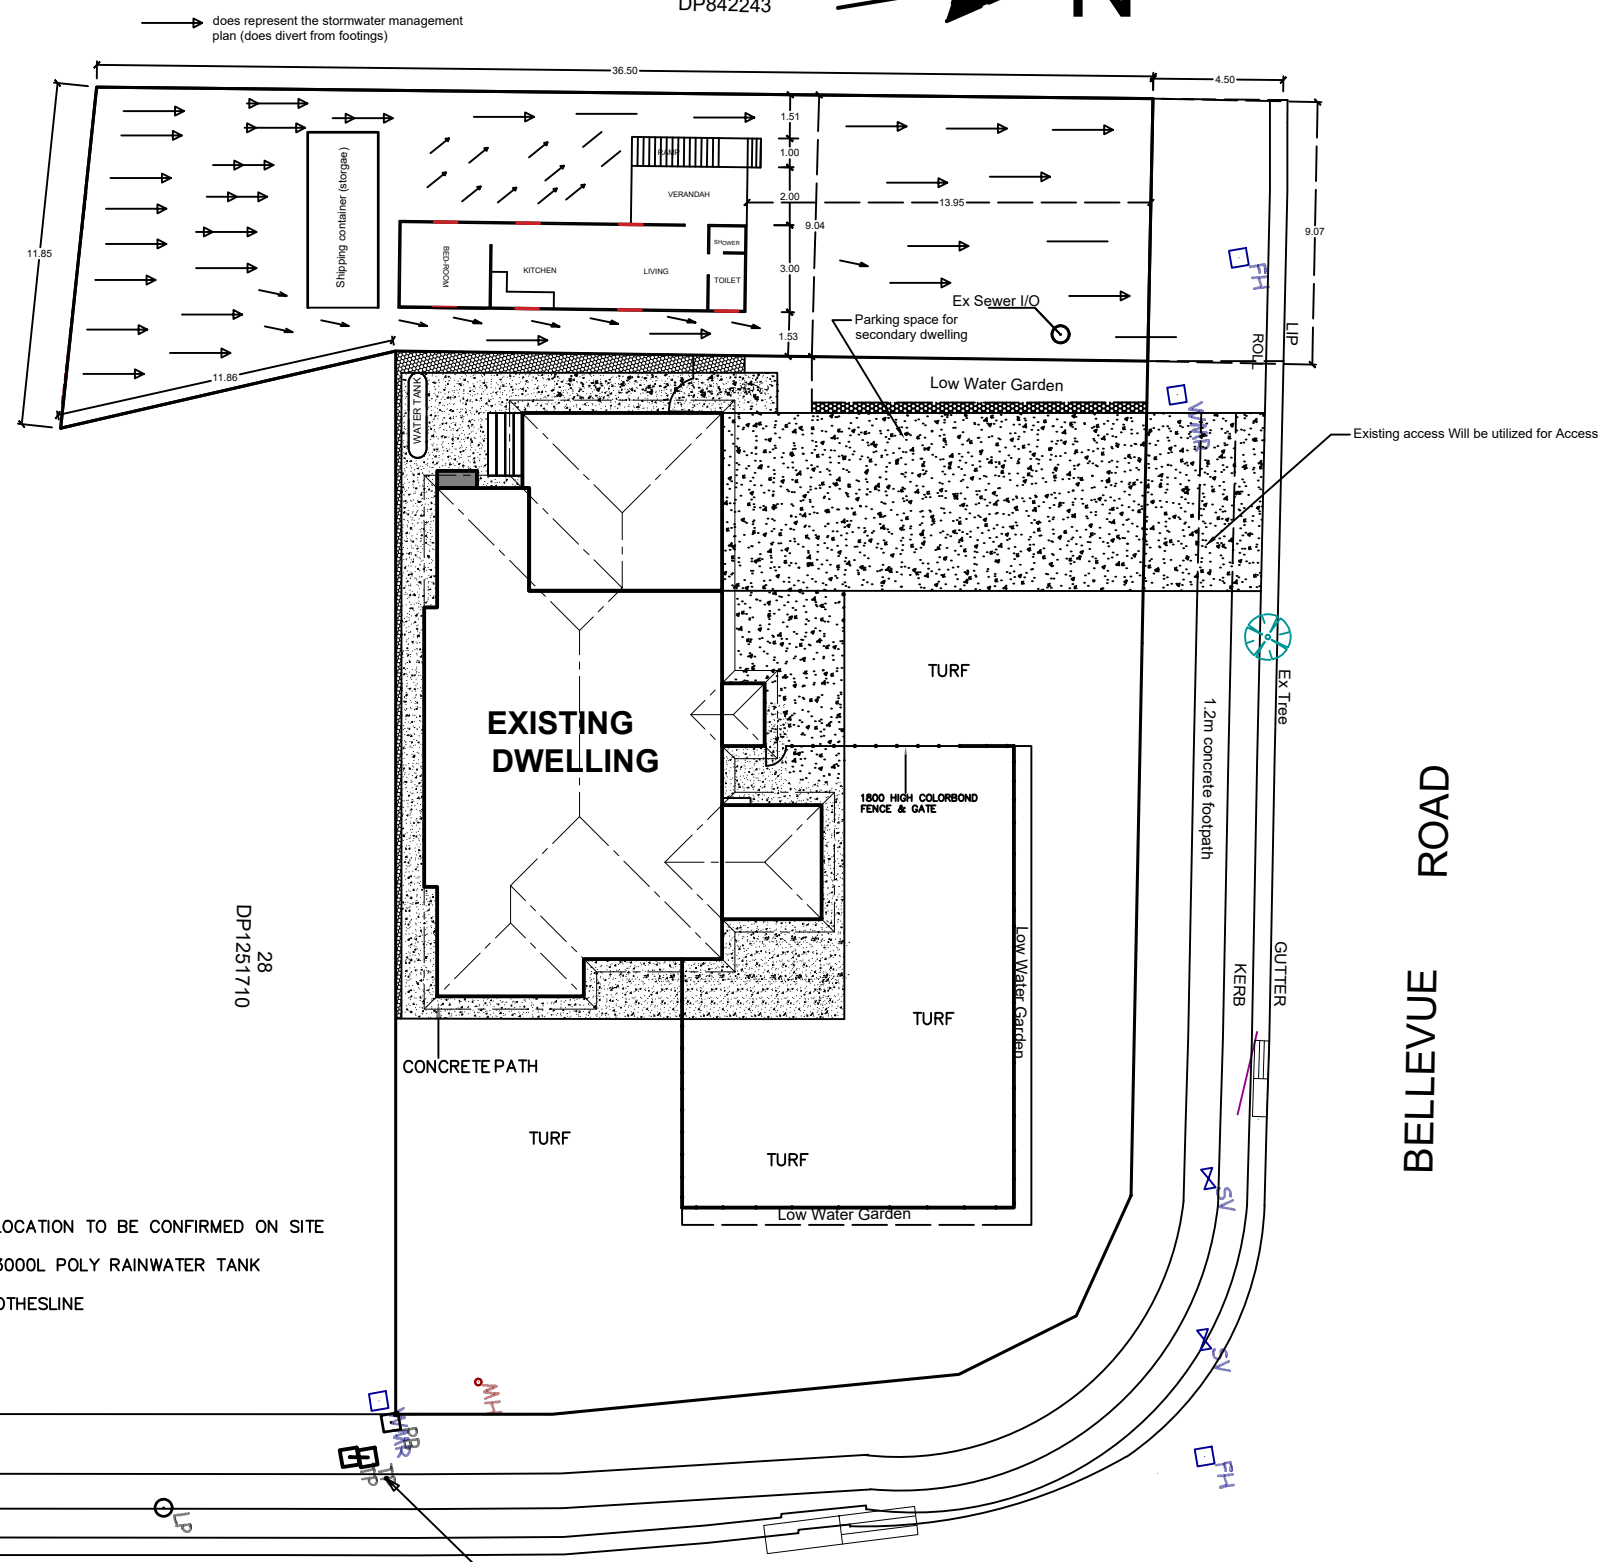

- LEGEND:
- A/C LOCATION TO BE CONFIRMED ON SITE
 - 3000L POLY RAINWATER TANK
 - CLOTHESLINE

* ALL DIMENSIONS ARE TO BE CONFIRMED BY THE BUILDER PRIOR TO CONSTRUCTION. DO NOT SCALE FROM DRAWINGS. BUILDING SET OUT & SITE BOUNDARY DETAILS TO BE CONFIRMED BY A SURVEYOR. ALL WORK TO BE CARRIED OUT TO RELEVANT STANDARDS AND BUILDING CODES.
* ALL SURFACE LEVELS AND FEATURE LOCATIONS ARE TO BE CONFIRMED PRIOR TO CONSTRUCTION

BM TELSTRA PIT
RL 487.61(A.H.D)

KILLKENNY AVENUE

BELLEVUE ROAD

Date	19/11/2023
Dwg Title	Site Plan 1/4
Drawn By	RT
Checked By	Umesh Pahari (RPEng)
Revision	A
Scale	1:250 for A3